



CITY OF ST PETER
622 Sunrise Drive
Saint Peter, MN 56082

ST PETER FIRE
STATION

SCHEMATIC DESIGN

Banbury Place, Building D04
800 Wisconsin Street, Suite 202
Eau Claire, WI 54703
www.wendelcompanies.com
p.715.832.4848 f.716.625.6825
WENDEL ARCHITECTURE, P.C.

ARCHITECT
WENDEL
ROBERT KRZYZANOWSKI, PROJECT MANAGER
JENNIFER POLACEK, AIA
BUILDING D04, SUITE 202, MAILBOX 2
800 WISCONSIN STREET
EAU CLAIRE, WI 54703
715.832.4848
rkrzyzanowski@wendelcompanies.com

CIVIL ENGINEER
COMPANY
CONTACT
ADDRESS 1
ADDRESS 2
PHONE
EMAIL

STRUCTURAL ENGINEER
COMPANY
CONTACT
ADDRESS 1
ADDRESS 2
PHONE
EMAIL

PLUMBING
COMPANY
CONTACT
ADDRESS 1
ADDRESS 2
PHONE
EMAIL


MECHANICAL
COMPANY
CONTACT
ADDRESS 1
ADDRESS 2
PHONE
EMAIL

ELECTRICAL
COMPANY
CONTACT
ADDRESS 1
ADDRESS 2
PHONE
EMAIL

NOTE
THIS DOCUMENT AND THE IDEAS AND DESIGNS INCORPORATED
HEREIN, AS AN INSTRUMENT OF PROFESSIONAL SERVICE, IS THE
PROPERTY OF THE ARCHITECT AND ENGINEER AND IS NOT TO BE
USED IN WHOLE OR IN PART, FOR ANY OTHER PROJECT WITHOUT THE
WRITTEN AUTHORIZATION OF THE ARCHITECT AND ENGINEER.
UNAUTHORIZED ALTERATION OR ADDITION TO ANY SURVEY
DRAWING, DESIGN, SPECIFICATION, PLAN OR REPORT IS PROHIBITED
IN ACCORDANCE WITH STATE LAW, CODE AND RULES.

NO.	REVISIONS	DATE

OVERALL FLOOR PLANS

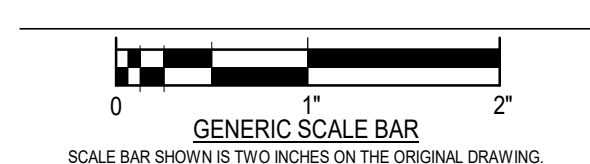


DATE 09/30/21
SCALE 1" = 10'-0"
DWN. Author CHK. Checker
PROJ. No. 16098
DWG. No.

AC102

BUILDING SQUARE FOOTAGE

APPARATUS BAYS	= 9,120 SF
APPARATUS SUPPORT	= 2,500 SF
TRAINING	= 3,620 SF
ADMINISTRATION	= 2,380 SF
MECHANICAL	= 350 SF
CIRCULATION	= 1,120 SF
ALTERNATE BAY	= 1,560 SF
FIRST FLOOR	= 20,650 SF
MEZZANINE	= 1,900 SF
TOTAL BUILDING AREA	= 22,550 SF
TOTAL W/O ALTERNATE	= 20,990 SF

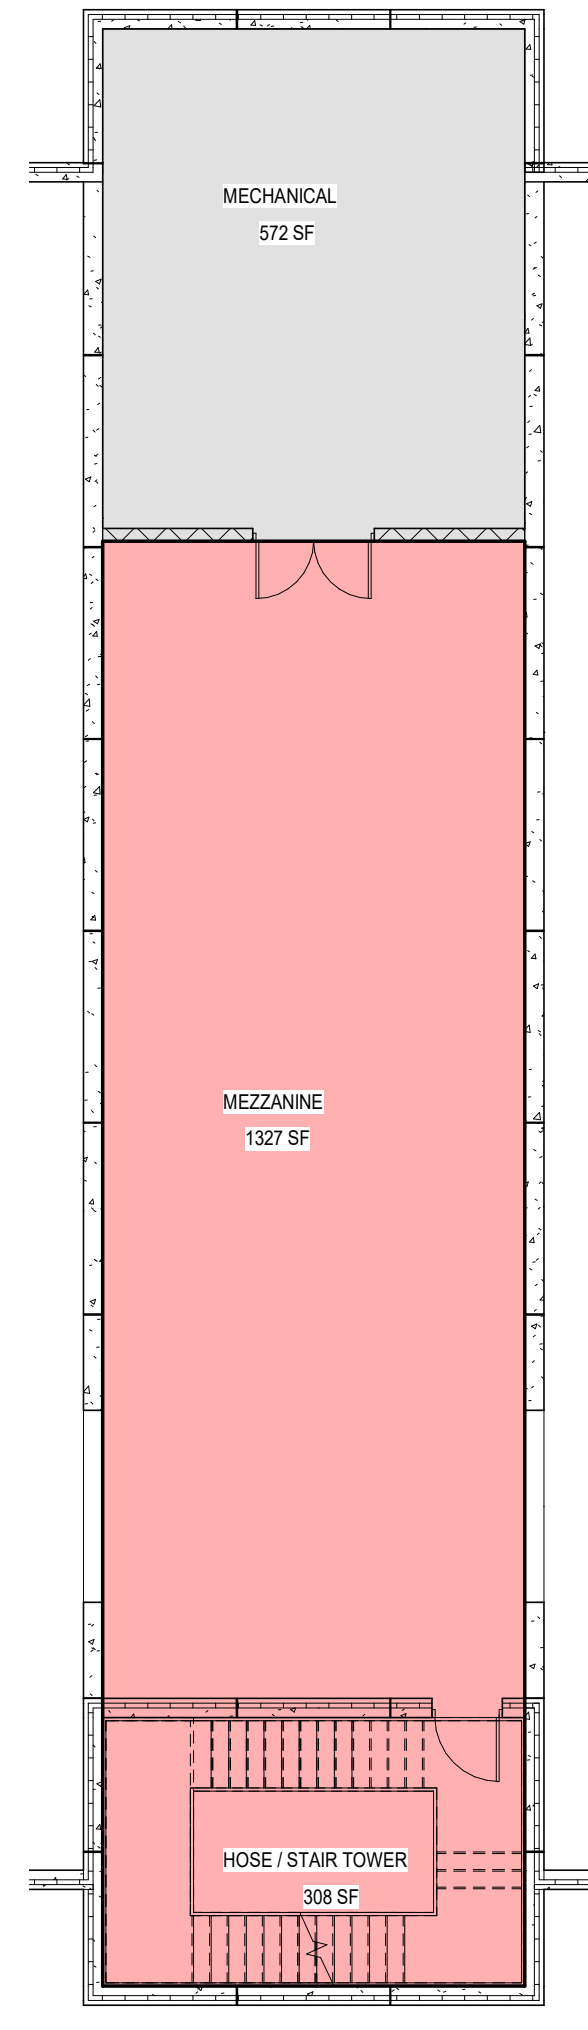

1 FIRST FLOOR PLAN
SCALE: 1" = 10'-0"

2 MEZZANINE PLAN
SCALE: 1" = 10'-0"

